


UNIT A PLAN (PRIME) - LEVEL 1
SCALE: 3/16" = 1'-0"

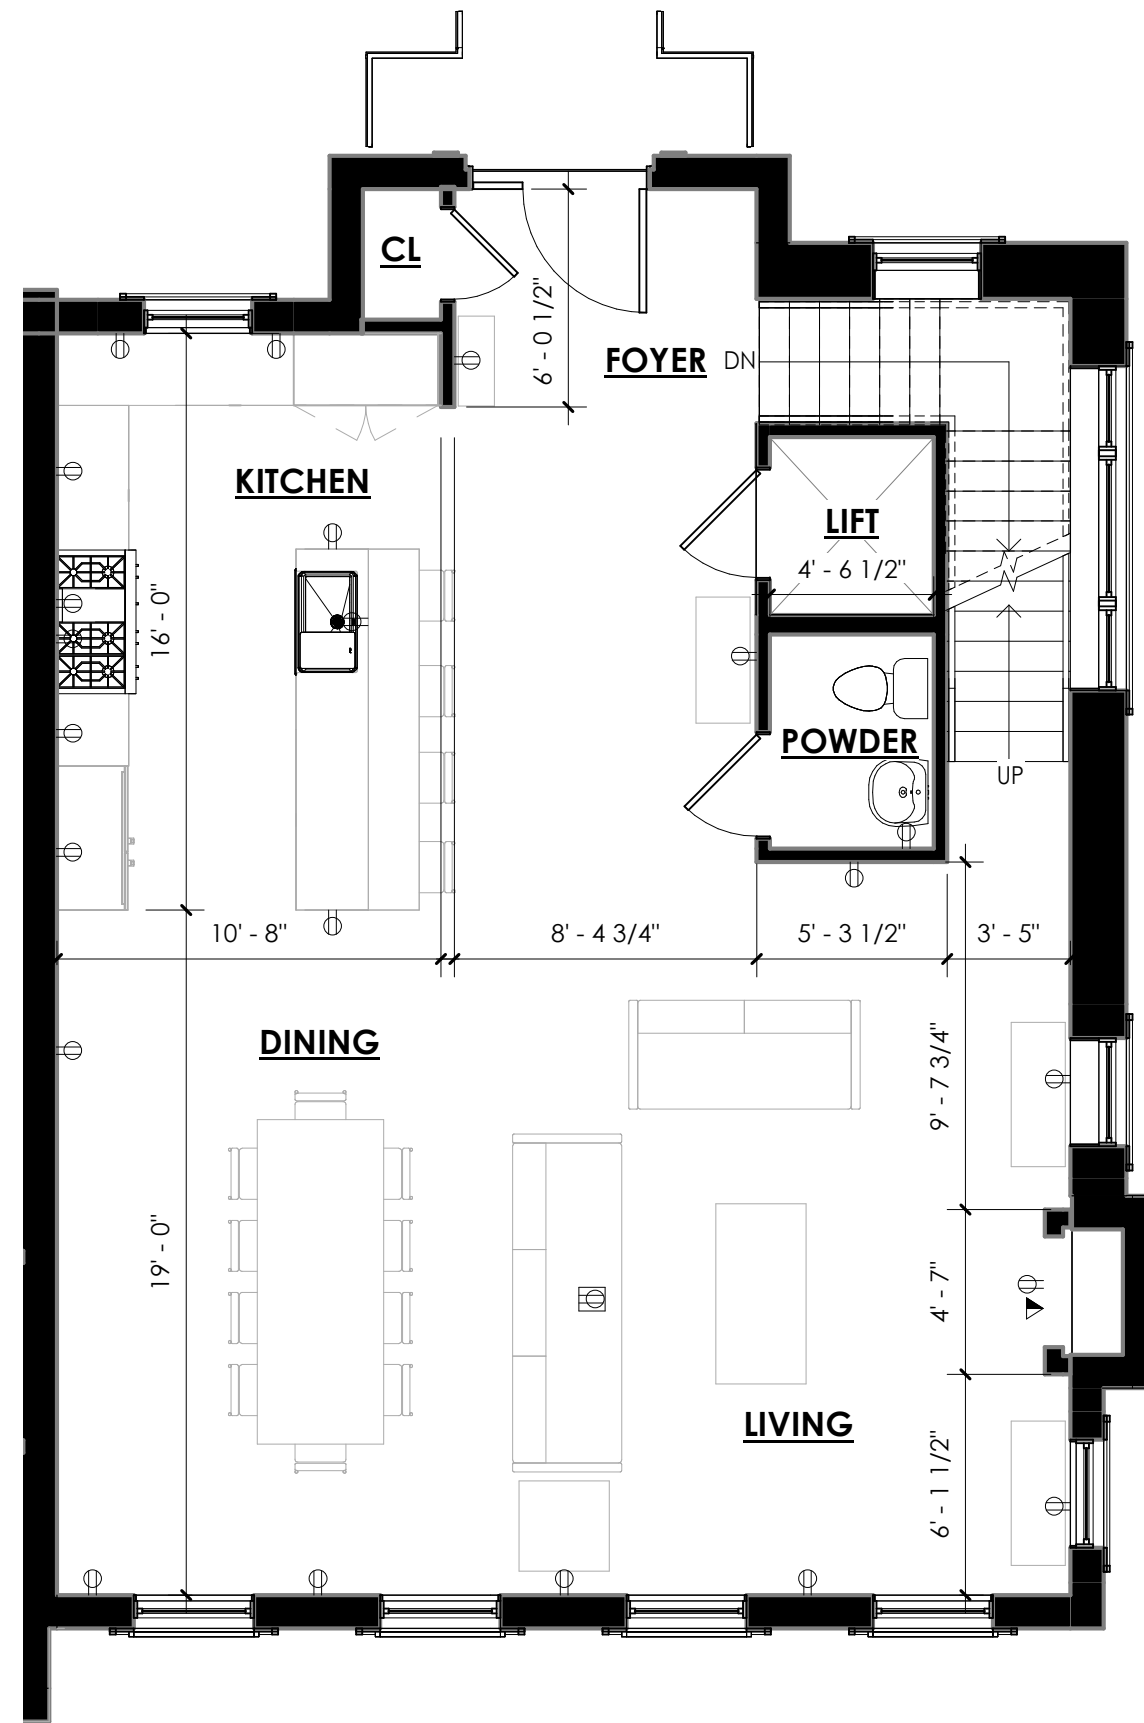


UNIT A PLAN (PRIME) - LEVEL 2
SCALE: 3/16" = 1'-0"

NOTES


1. DIMENSIONS SUBJECT TO CHANGE DUE TO CONSTRUCTION TOLERANCES AND FINAL PERMITTING REQUIREMENTS
2. ALL DIMENSIONS ARE TAKEN TO FINISHED FACE OF WALL

ELECTRICAL LEGEND

	DATA/VOICE
	DUPLEX RECEPTACLE
	QUADRUPLEX RECEPTACLE
	DUPLEX FLOOR RECEPTACLE

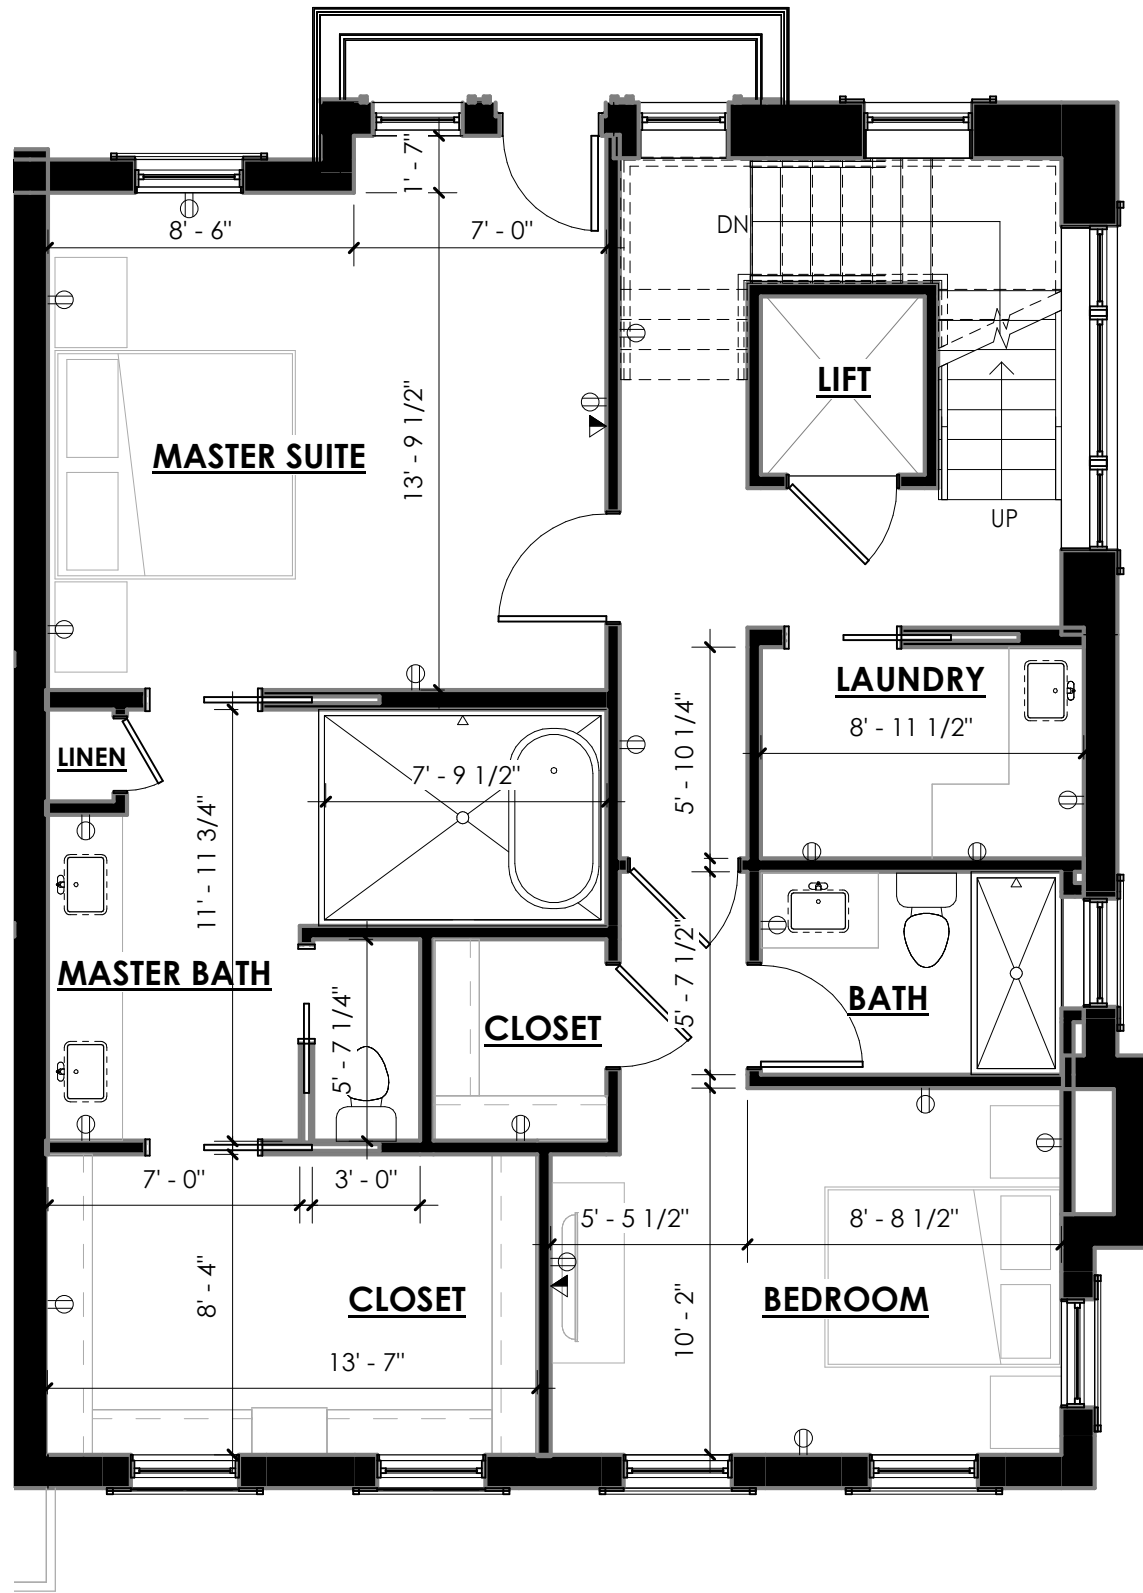

UNIT A PLAN (PRIME) - LEVEL 3
SCALE: 3/16" = 1'-0"

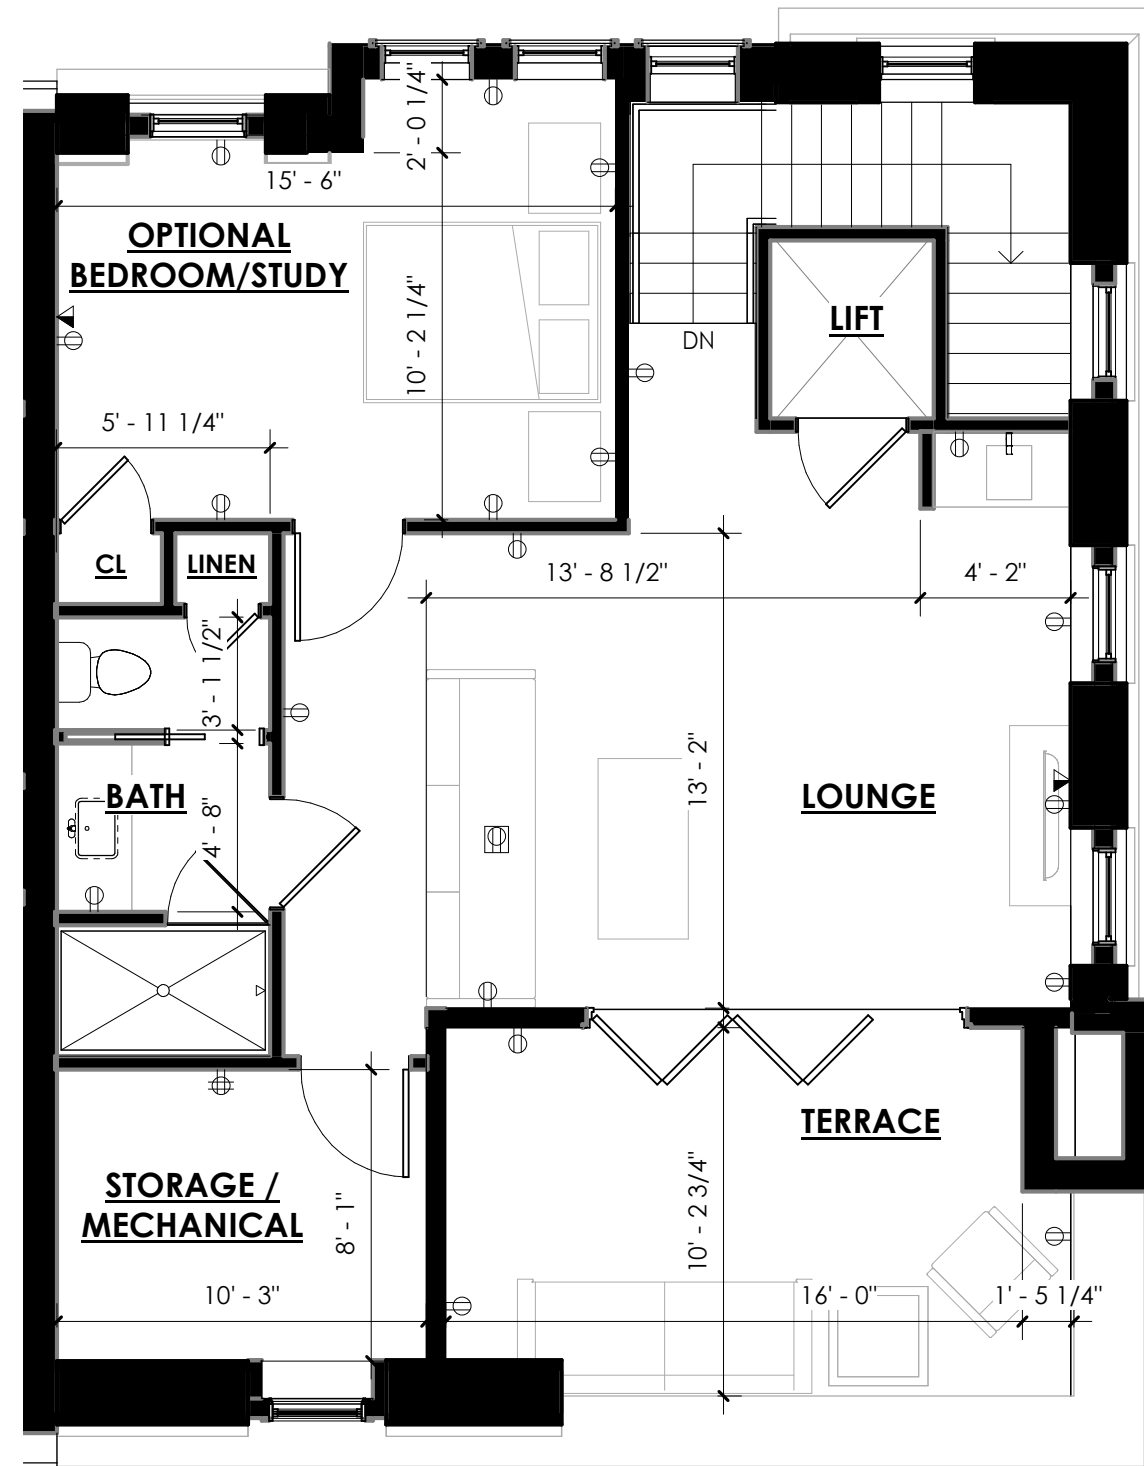

UNIT A PLAN (PRIME) - LEVEL 4
SCALE: 3/16" = 1'-0"


NOTES

1. DIMENSIONS SUBJECT TO CHANGE DUE TO CONSTRUCTION TOLERANCES AND FINAL PERMITTING REQUIREMENTS
2. ALL DIMENSIONS ARE TAKEN TO FINISHED FACE OF WALL


ELECTRICAL LEGEND

	DATA/VOICE
	DUPLEX RECEPTACLE
	QUADRUPLUX RECEPTACLE
	DUPLEX FLOOR RECEPTACLE

The McDaniel

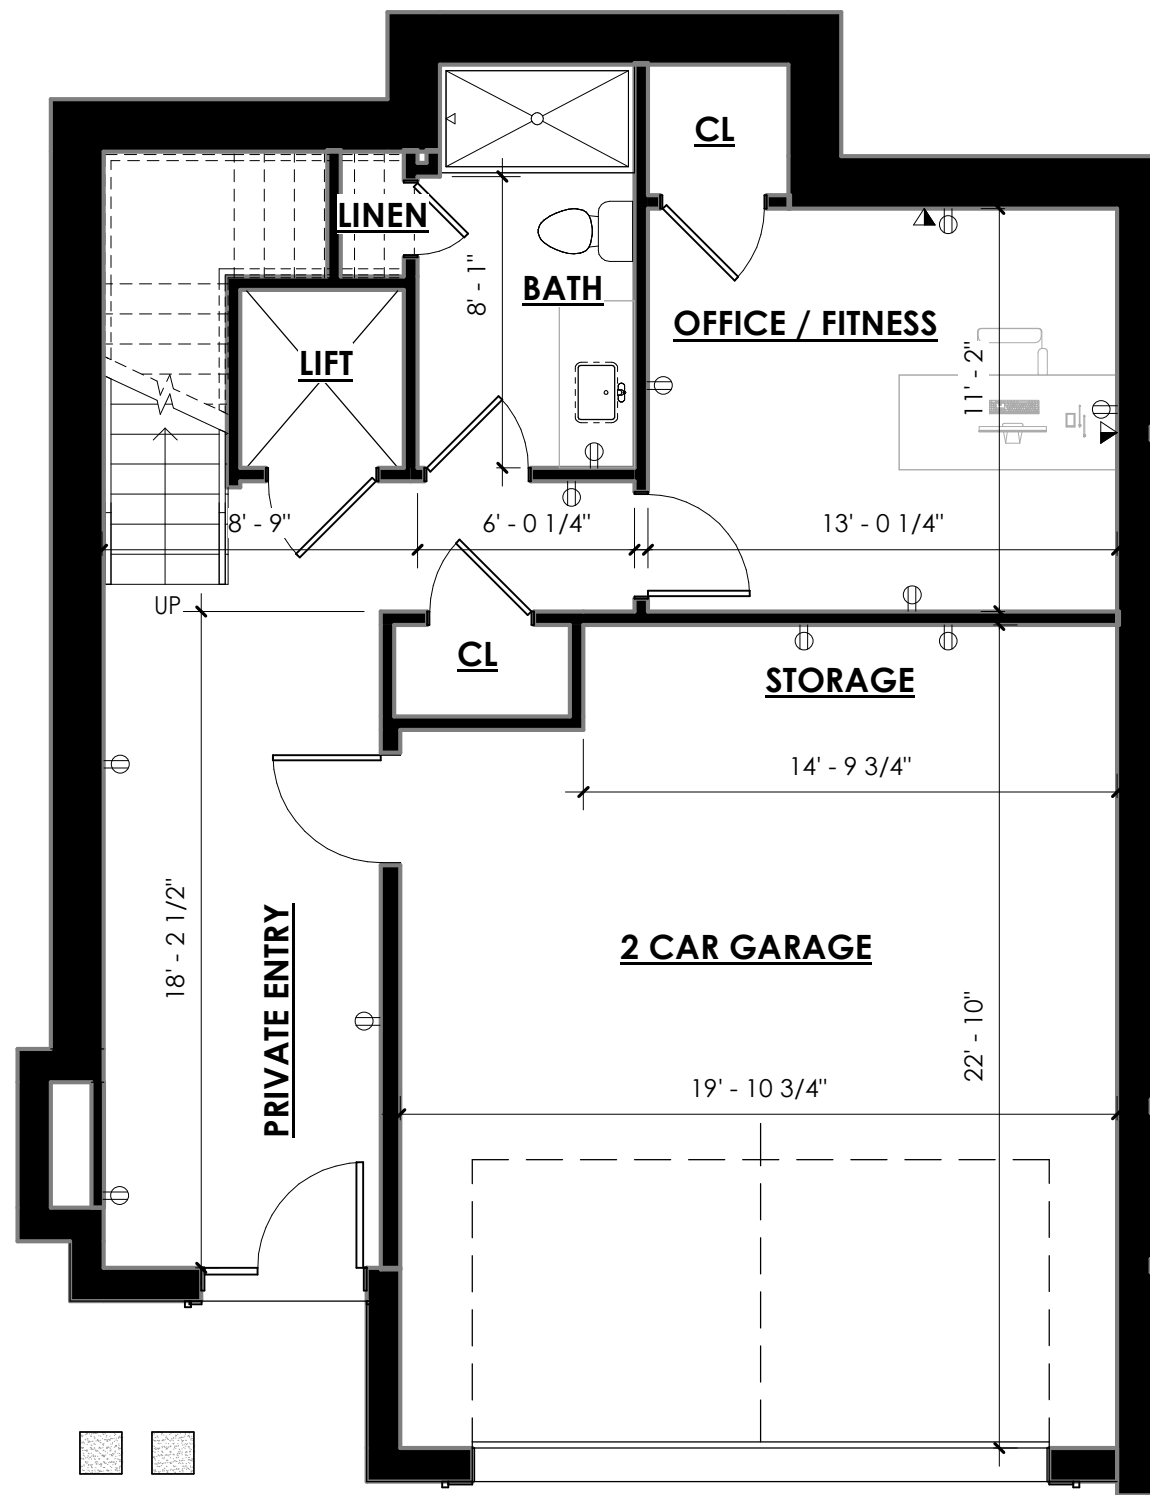

UNIT A PLAN - LEVEL 1
SCALE: 3/16" = 1'-0"

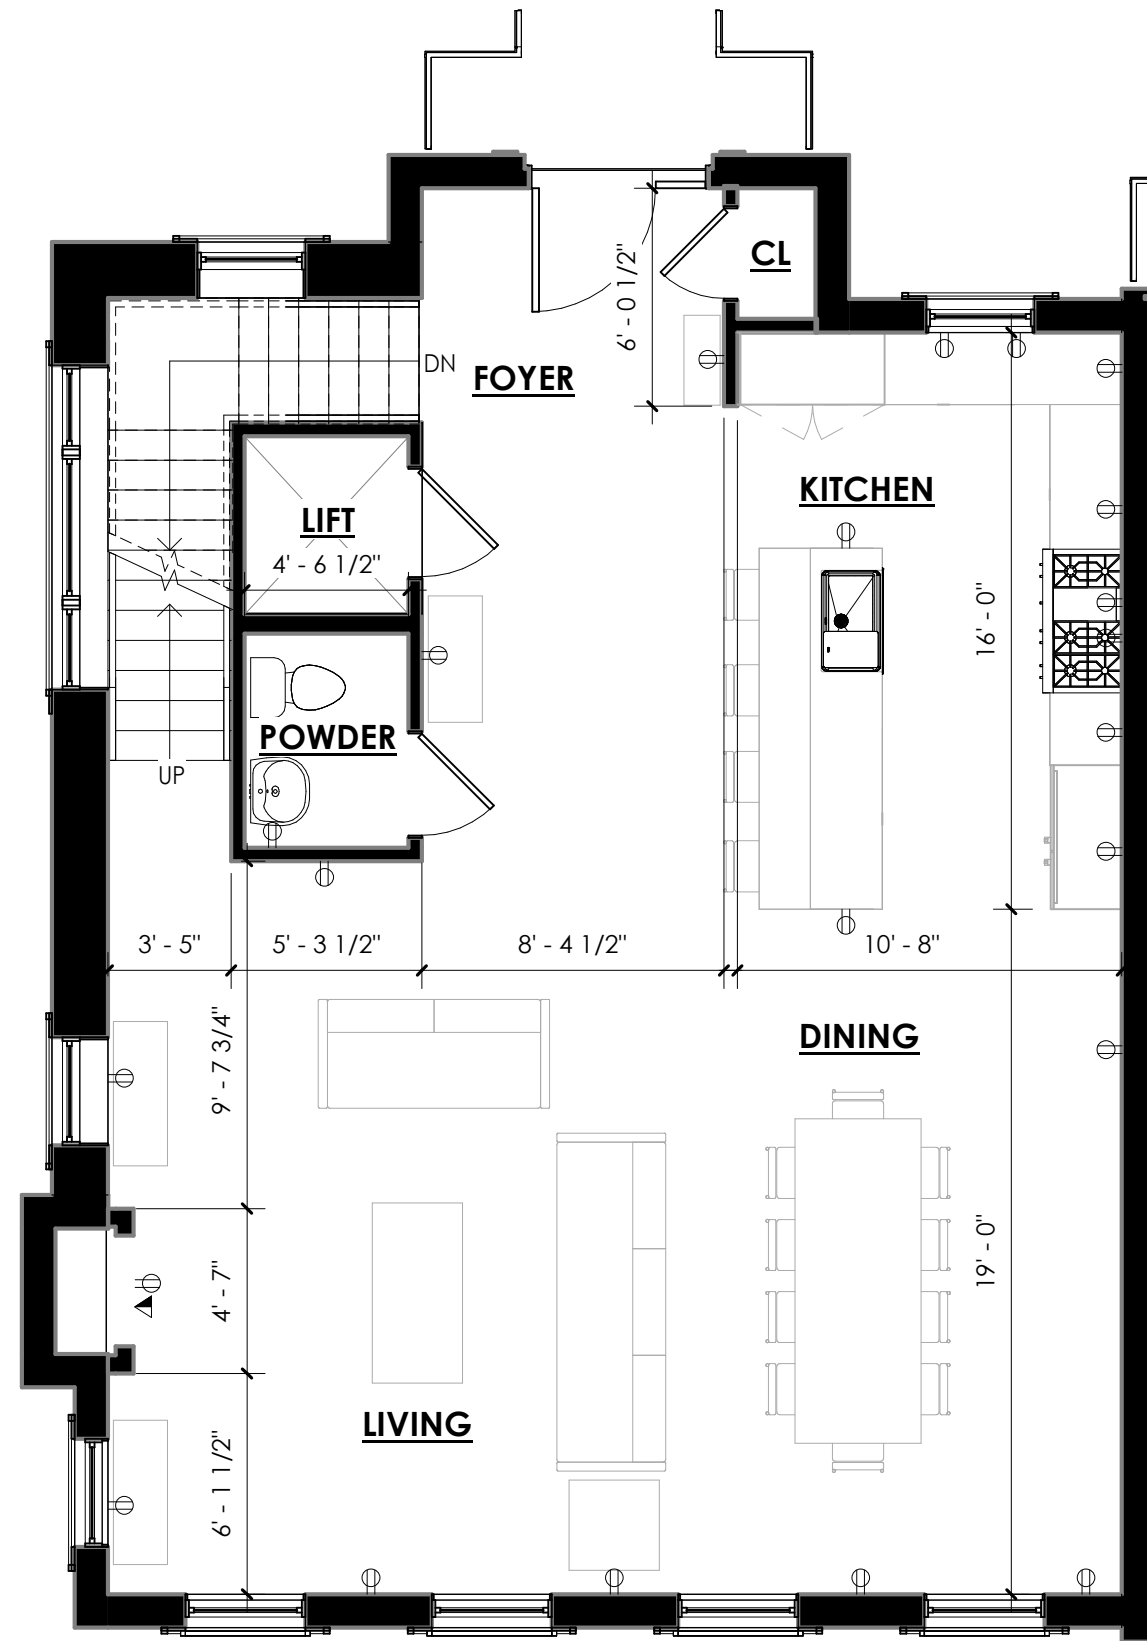





UNIT A PLAN - LEVEL 2
SCALE: 3/16" = 1'-0"


PANTRY

NOTES

1. DIMENSIONS SUBJECT TO CHANGE DUE TO CONSTRUCTION TOLERANCES AND FINAL PERMITTING REQUIREMENTS
2. ALL DIMENSIONS ARE TAKEN TO FINISHED FACE OF WALL


ELECTRICAL LEGEND

-  DATA/VOICE
-  DUPLEX RECEPTACLE
-  QUADRUPLIX RECEPTACLE
-  DUPLEX FLOOR RECEPTACLE

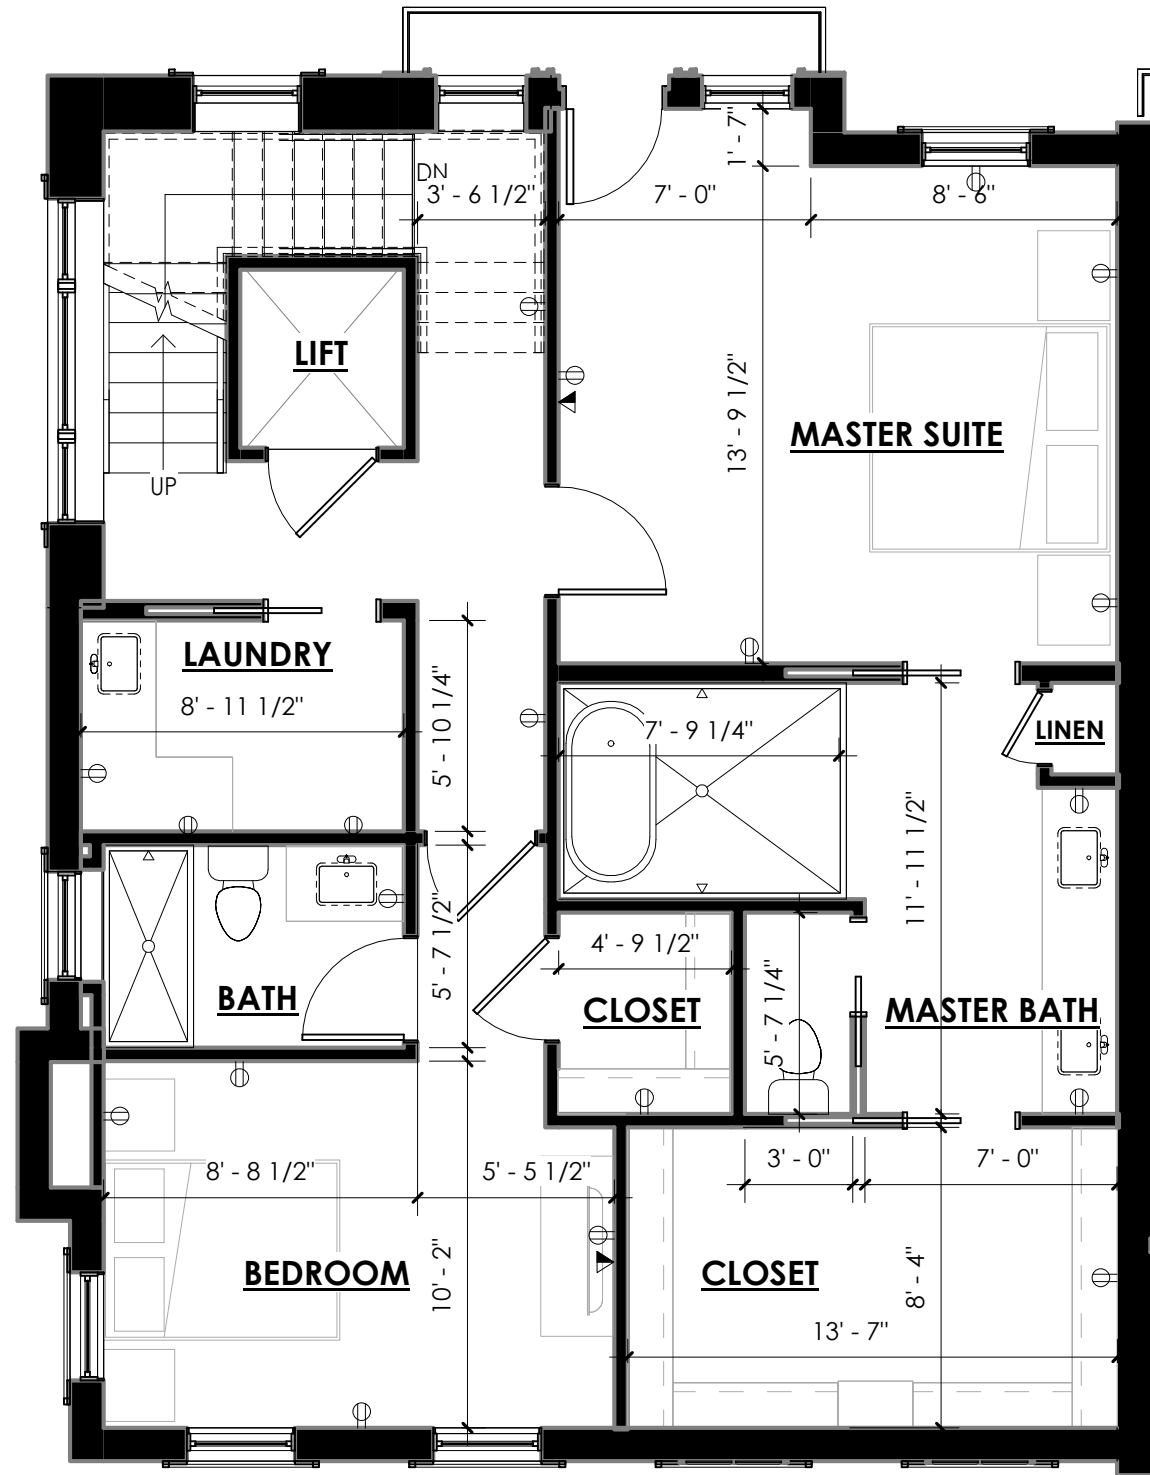

UNIT A PLAN - LEVEL 3

SCALE: 3/16" = 1'-0"

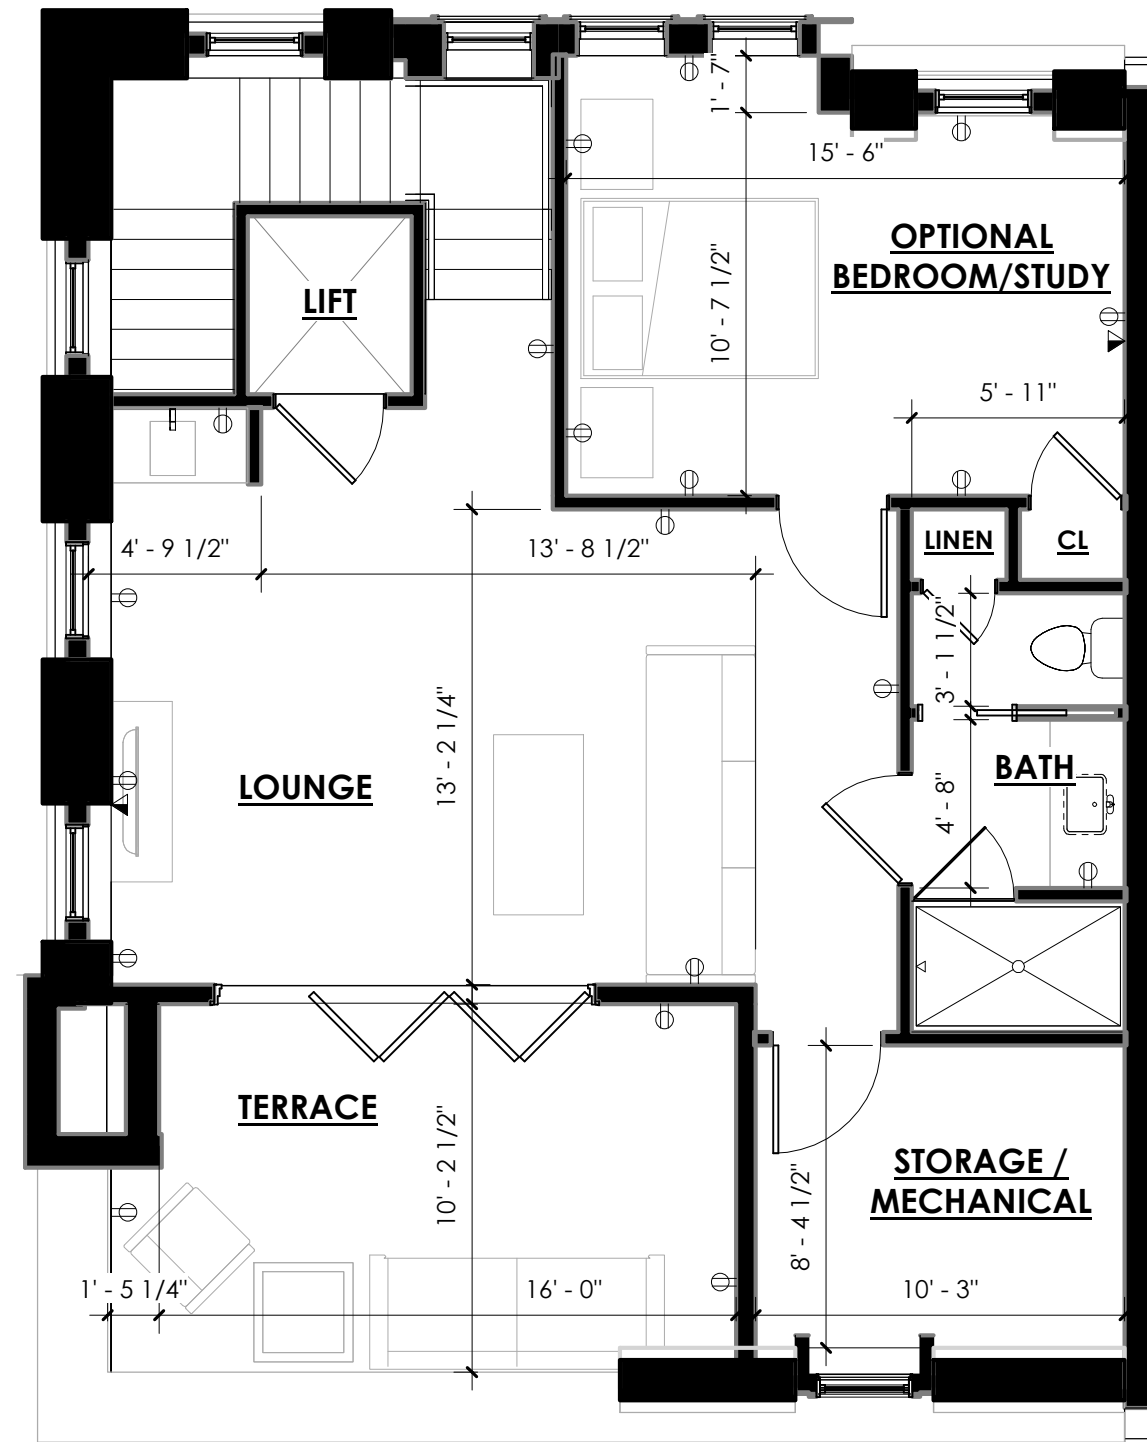

UNIT A PLAN - LEVEL 4

SCALE: 3/16" = 1'-0"

NOTES

1. DIMENSIONS SUBJECT TO CHANGE DUE TO CONSTRUCTION TOLERANCES AND FINAL PERMITTING REQUIREMENTS
2. ALL DIMENSIONS ARE TAKEN TO FINISHED FACE OF WALL

ELECTRICAL LEGEND

	DATA/VOICE
	DUPLEX RECEPTACLE
	QUADRUPLEX RECEPTACLE
	DUPLEX FLOOR RECEPTACLE