


**NOTES**

1. DIMENSIONS SUBJECT TO CHANGE DUE TO CONSTRUCTION TOLERANCES AND FINAL PERMITTING REQUIREMENTS
2. ALL DIMENSIONS ARE TAKEN TO FINISHED FACE OF WALL


**ELECTRICAL LEGEND**

	DATA/VOICE
	DUPLEX RECEPTACLE
	QUADRUPLIX RECEPTACLE
	DUPLEX FLOOR RECEPTACLE

The McDaniel

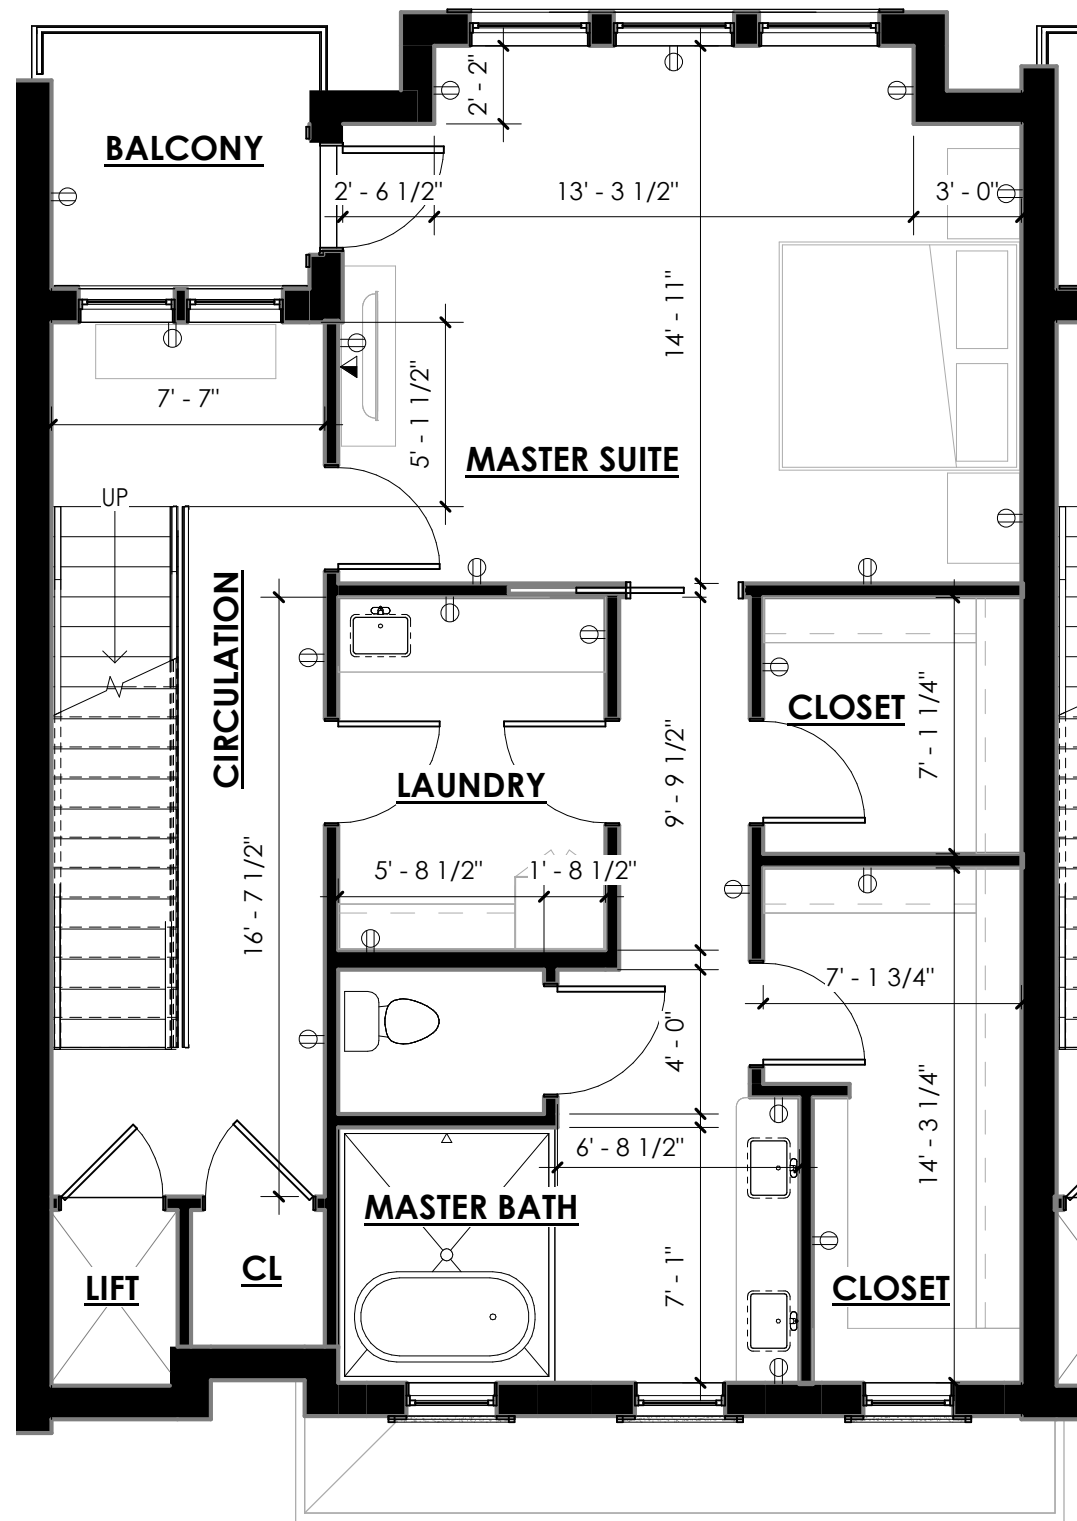

UNIT B PLAN (PRIME) - LEVEL 3  
SCALE: 3/16" = 1'-0"

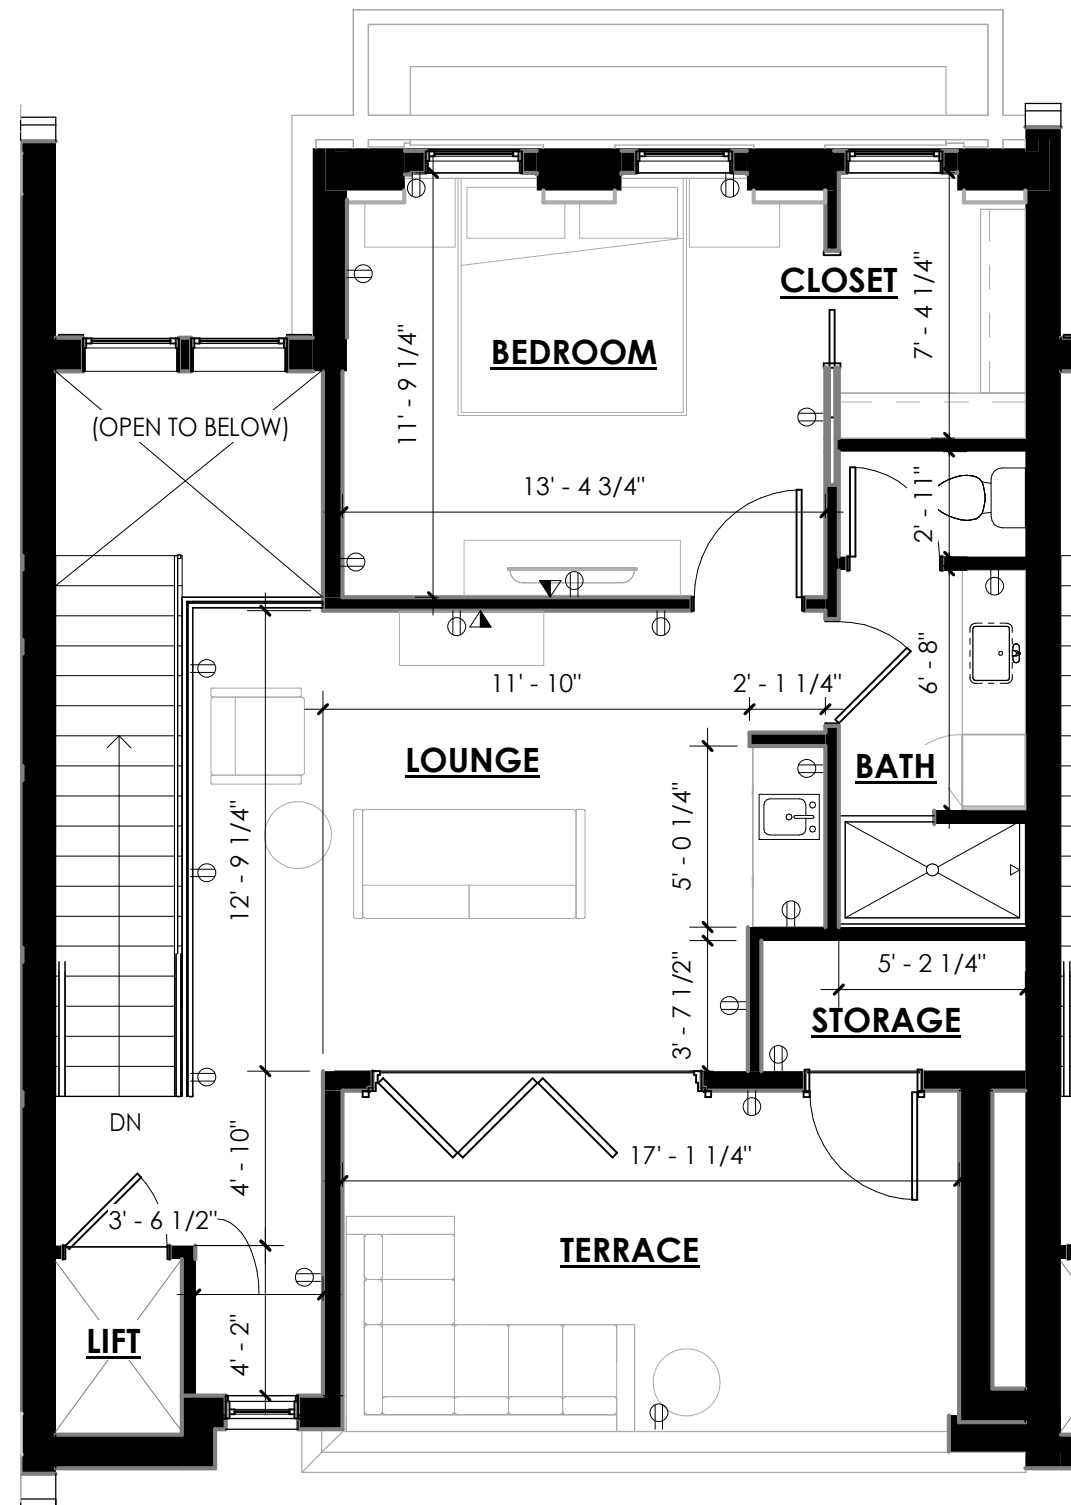


UNIT B PLAN (PRIME) - LEVEL 4  
SCALE: 3/16" = 1'-0"

**NOTES**

1. DIMENSIONS SUBJECT TO CHANGE DUE TO CONSTRUCTION TOLERANCES AND FINAL PERMITTING REQUIREMENTS
2. ALL DIMENSIONS ARE TAKEN TO FINISHED FACE OF WALL


**ELECTRICAL LEGEND**

	DATA/VOICE
	DUPLEX RECEPTACLE
	QUADRUPLIX RECEPTACLE
	DUPLEX FLOOR RECEPTACLE

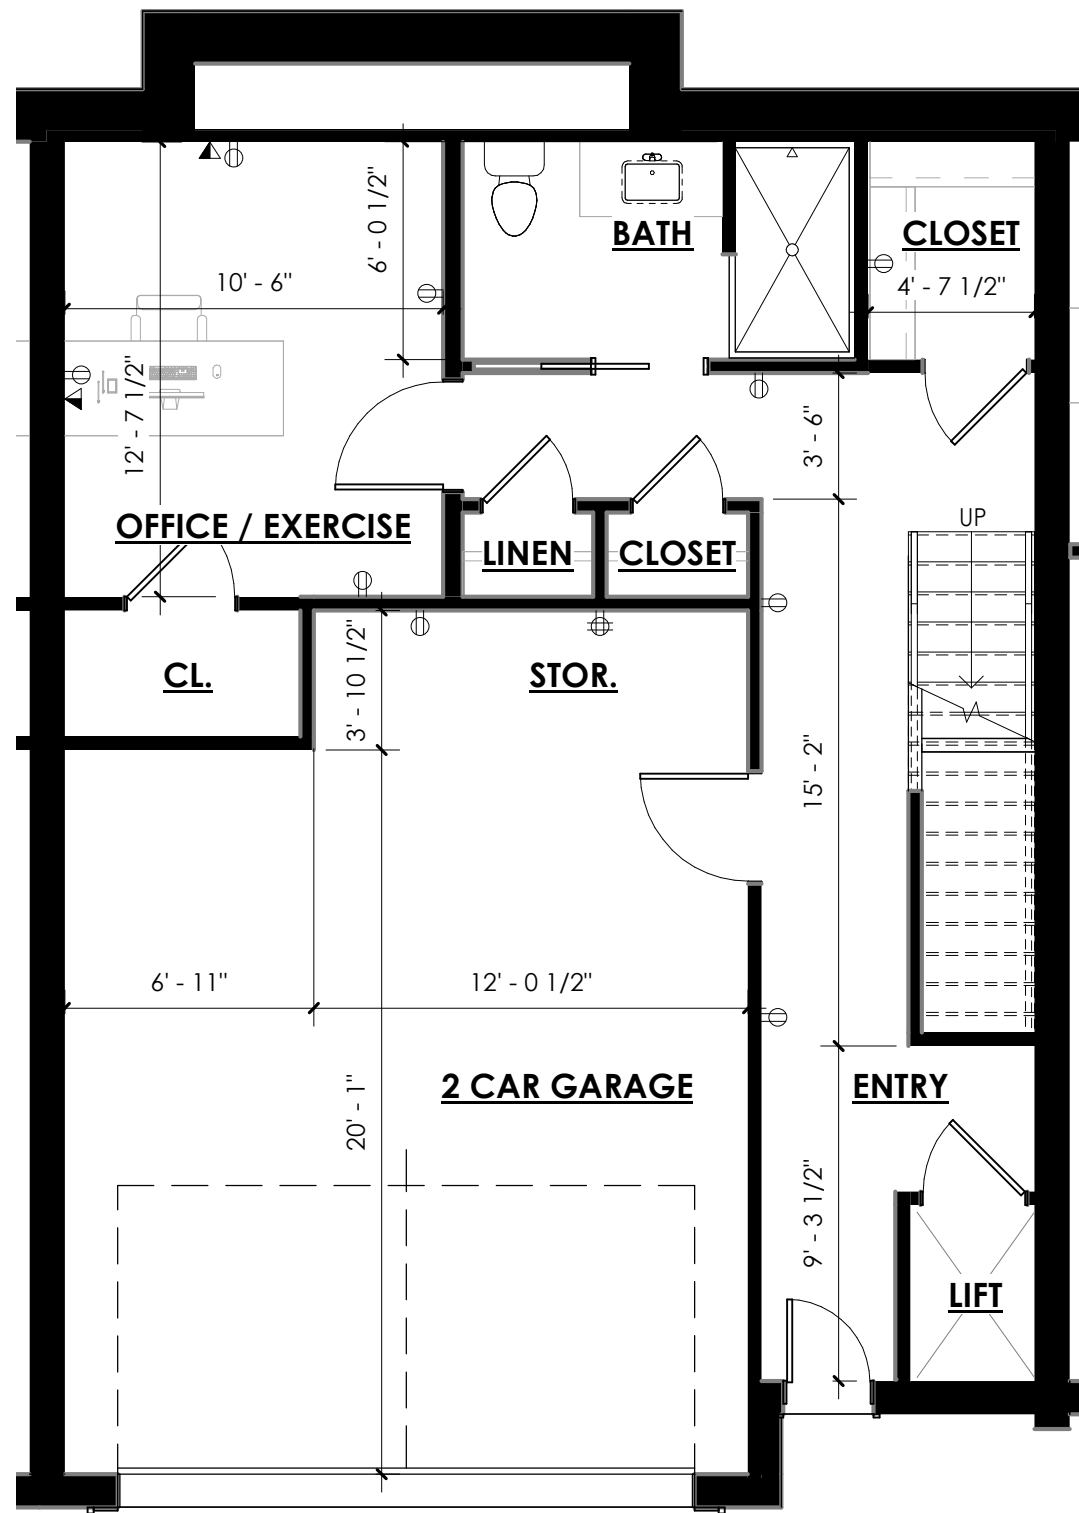

UNIT B PLAN - LEVEL 1

SCALE: 3/16" = 1'-0"

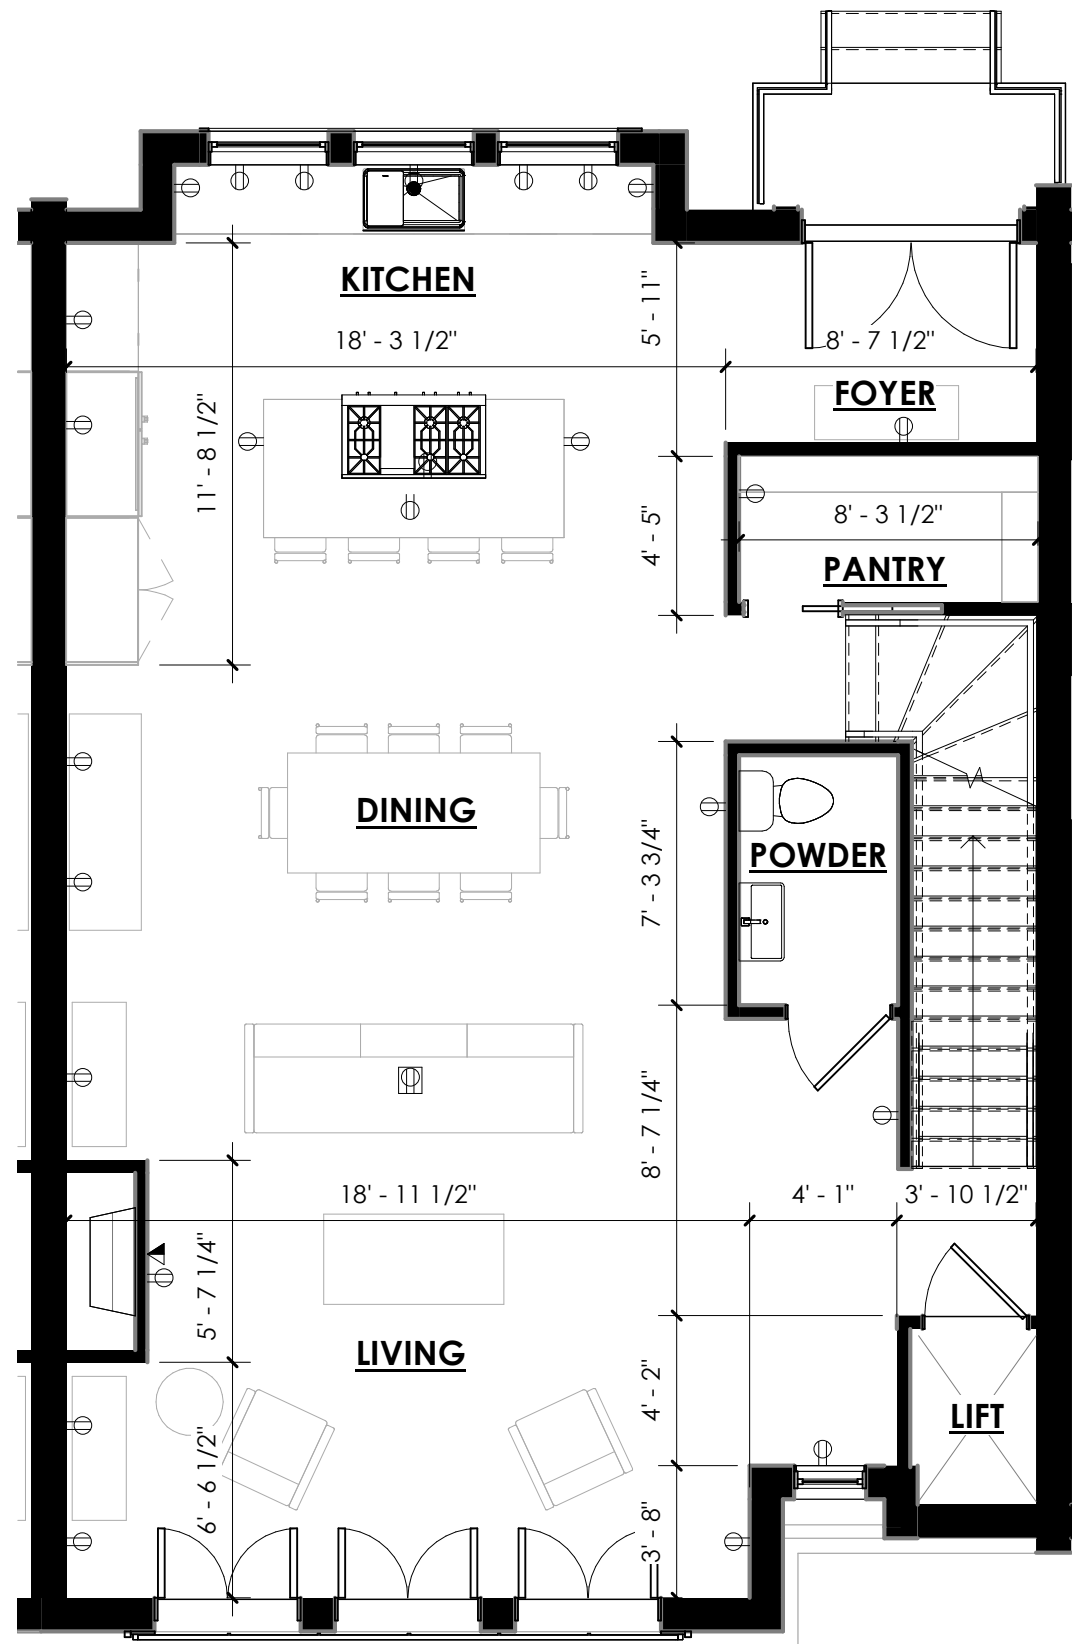





UNIT B PLAN - LEVEL 2

SCALE: 3/16" = 1'-0"


NOTES

1. DIMENSIONS SUBJECT TO CHANGE DUE TO CONSTRUCTION TOLERANCES AND FINAL PERMITTING REQUIREMENTS
2. ALL DIMENSIONS ARE TAKEN TO FINISHED FACE OF WALL

ELECTRICAL LEGEND


-  DATA/VOICE
-  DUPLEX RECEPTACLE
-  QUADRUPLIX RECEPTACLE
-  DUPLEX FLOOR RECEPTACLE

The McDaniel

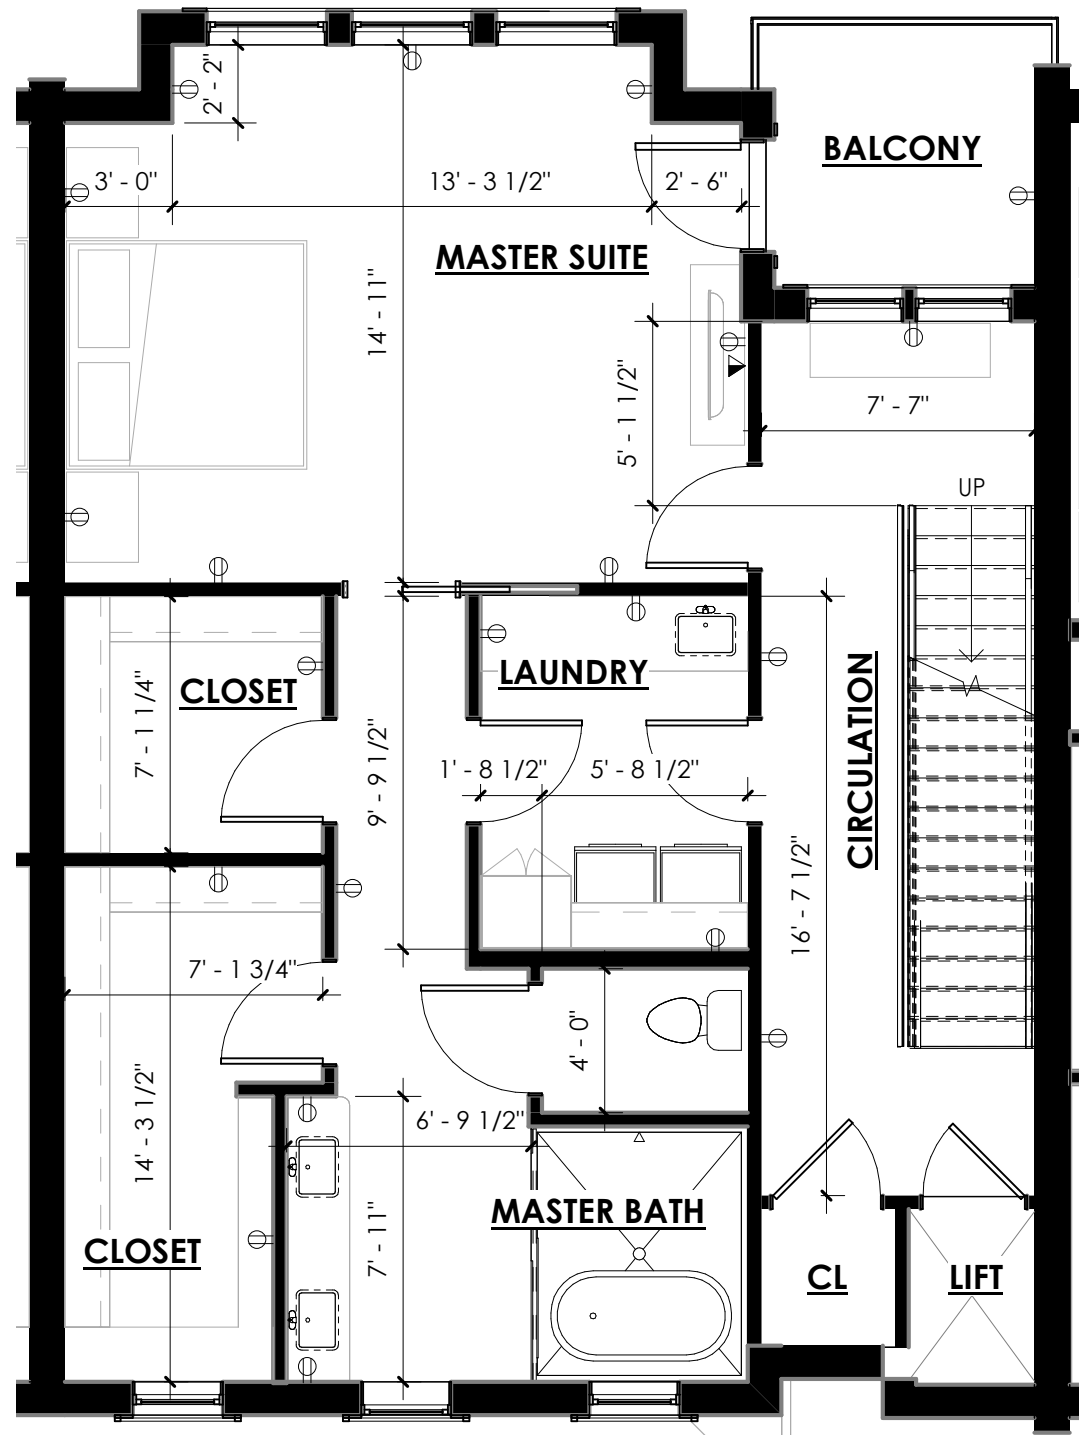

UNIT B PLAN - LEVEL 3

SCALE: 3/16" = 1'-0"

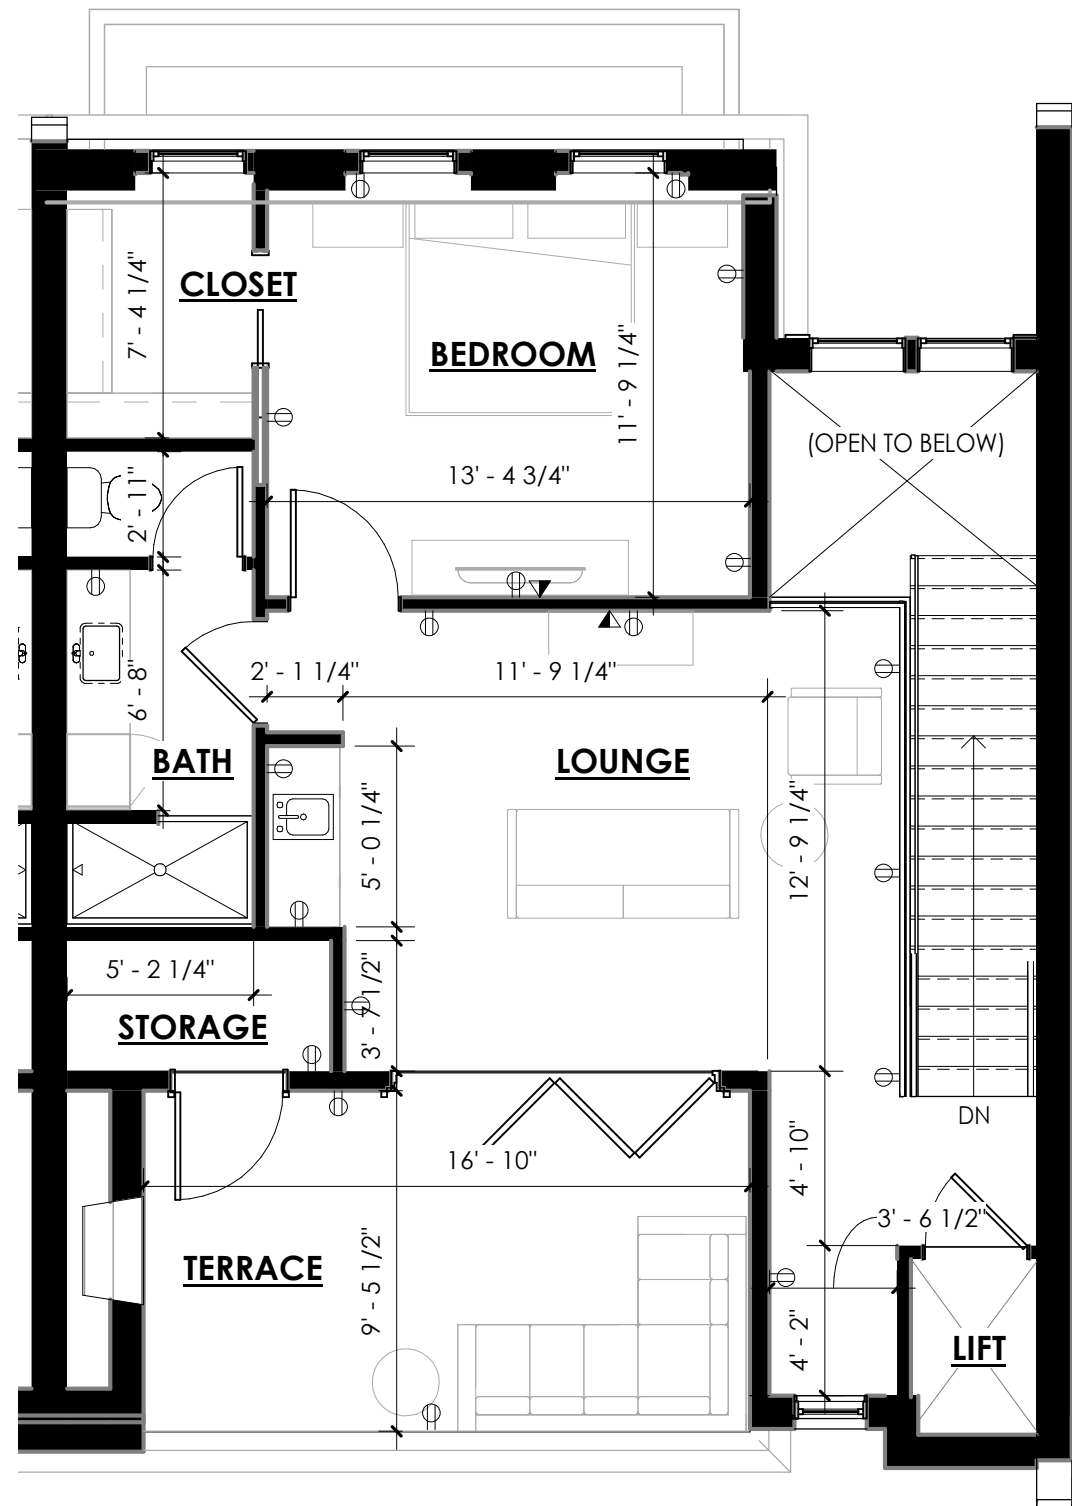





UNIT B PLAN - LEVEL 4

SCALE: 3/16" = 1'-0"

NOTES

1. DIMENSIONS SUBJECT TO CHANGE DUE TO CONSTRUCTION TOLERANCES AND FINAL PERMITTING REQUIREMENTS
2. ALL DIMENSIONS ARE TAKEN TO FINISHED FACE OF WALL

ELECTRICAL LEGEND

-  DATA/VOICE
-  DUPLEX RECEPTACLE
-  QUADRUPLIX RECEPTACLE
-  DUPLEX FLOOR RECEPTACLE

The McDaniel